



1 Proposed Context Elevation
North
500

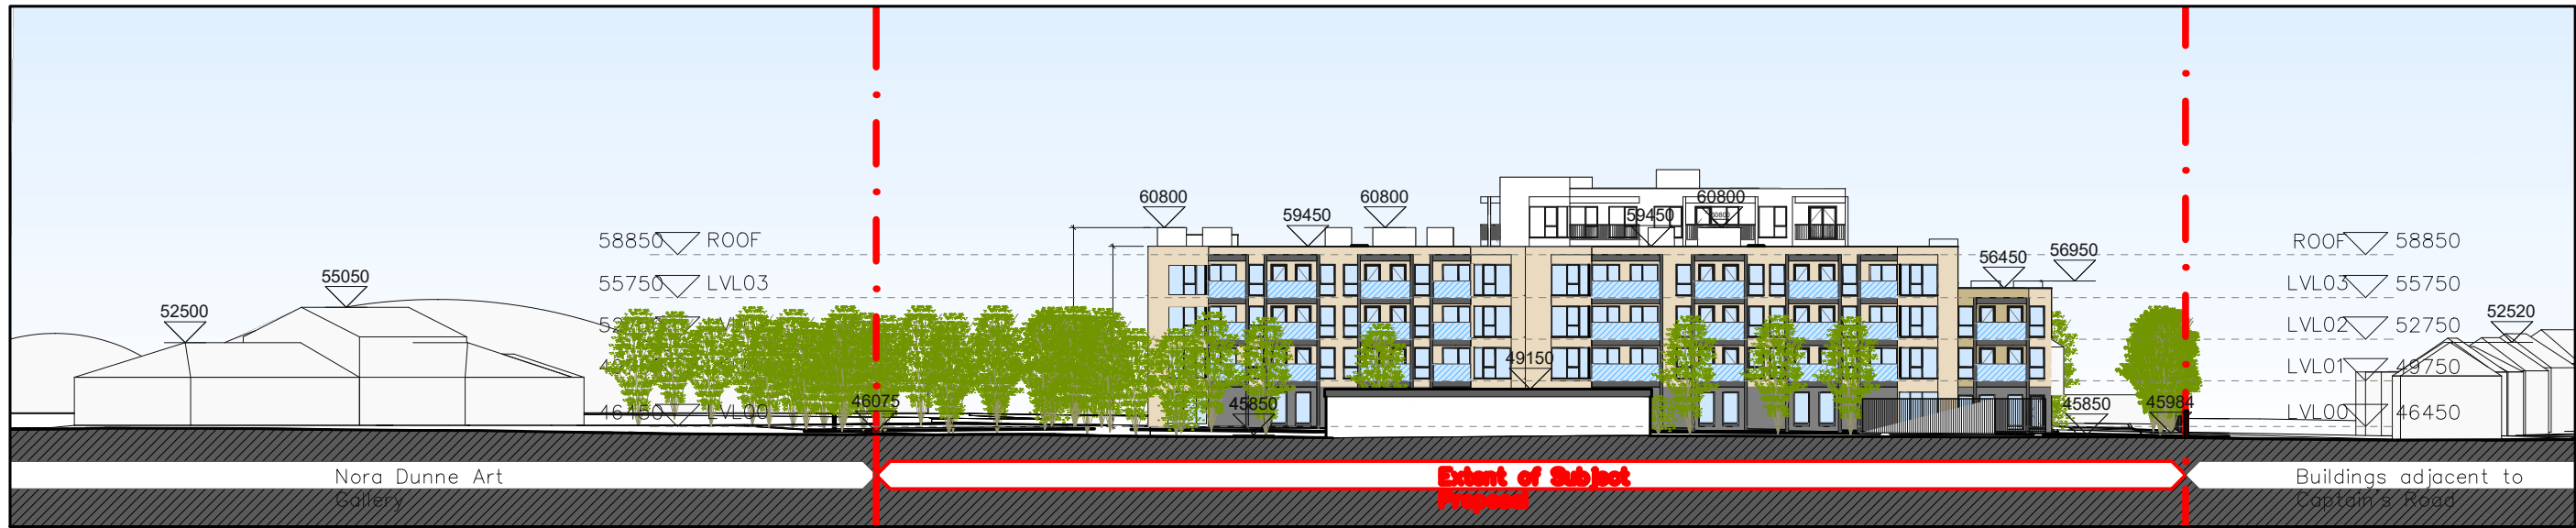


2 Proposed Context Elevation
South
500



3 Proposed Context Elevation
East
500

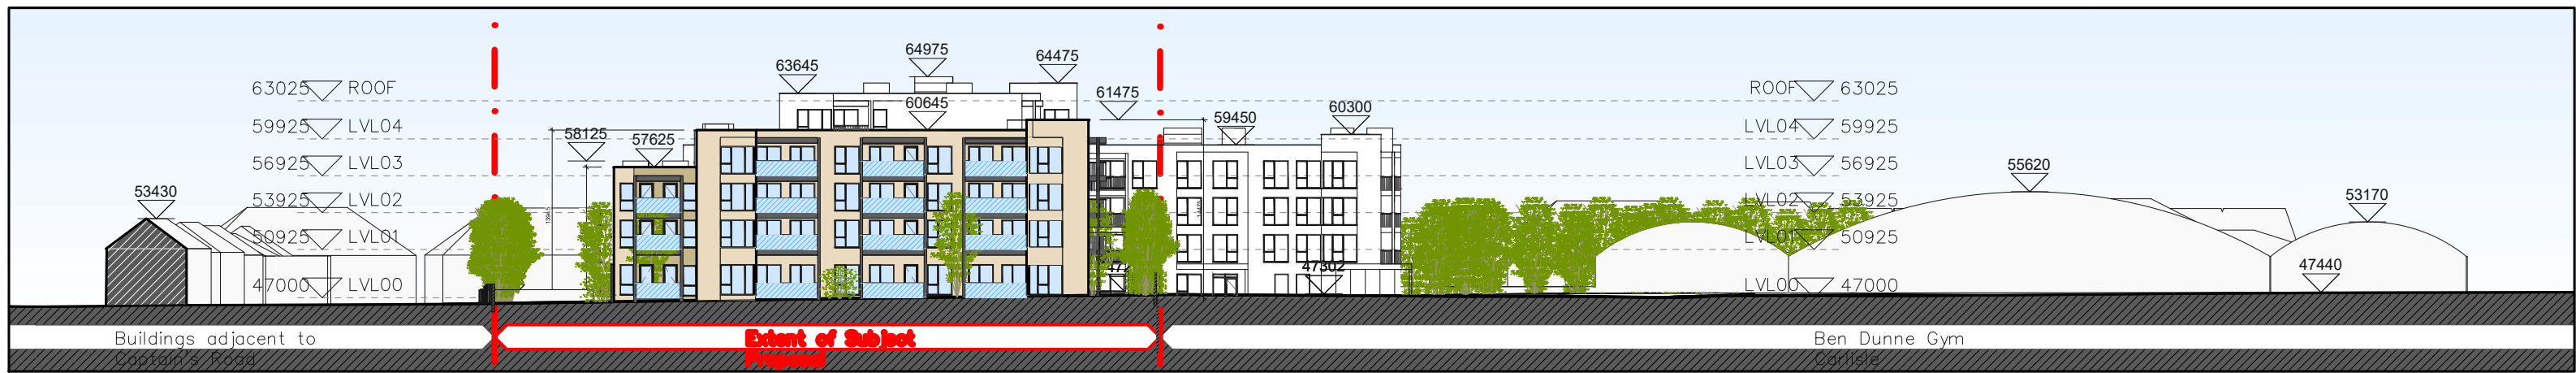

4 Proposed Context Elevation
West
500

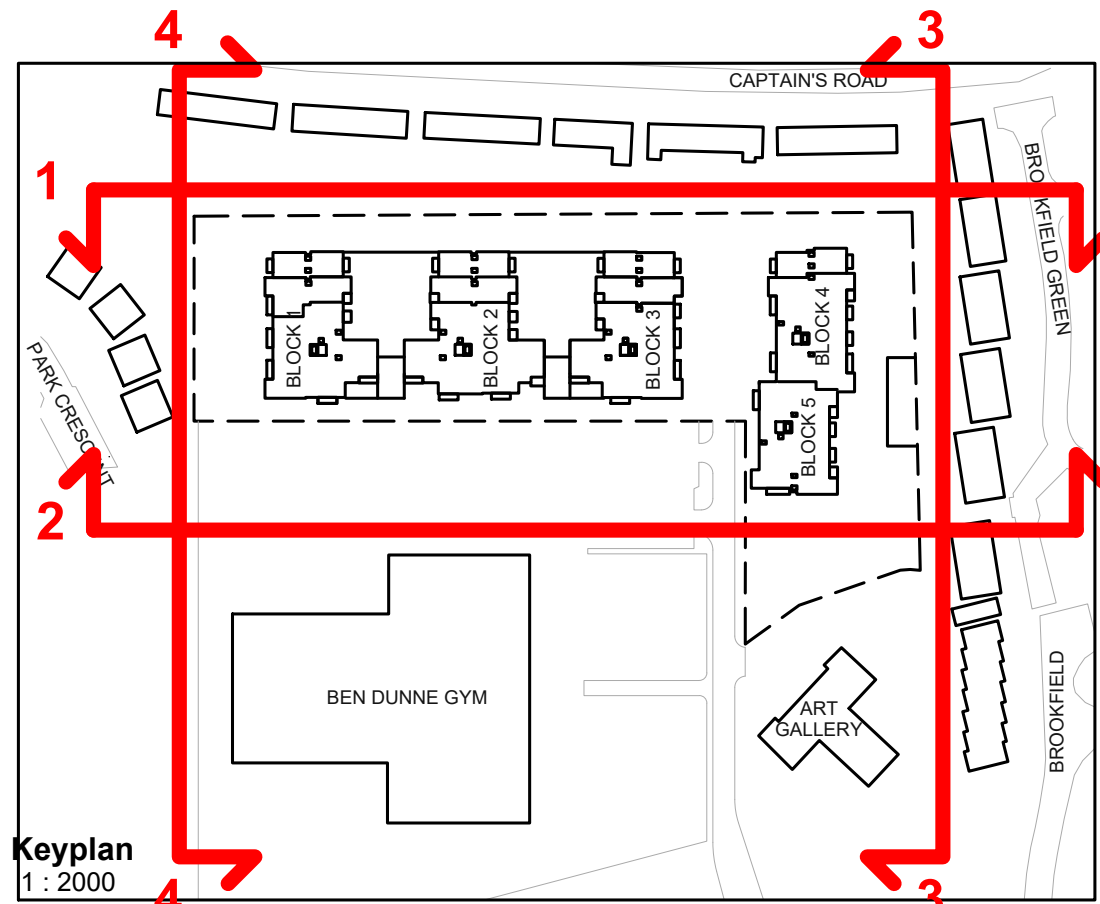

Notes		Issue Status	
1. Copyright Reserved			
2. Work to figure dimensions only. Do not scale drawing			
3. The contractor is responsible for checking all levels and dimensions on site and shall refer all discrepancies to the Architect			
4. Where appropriate, for details of r.c. structure, or mechanical and electrical details, see Engineers drawings			
5. Proprietary items shall be fixed in strict accordance with manufacturers instructions.			
6. Sizes of proprietary items shall be checked with manufacturer.			
7. The contractor shall be responsible for the coordination of structure, finishes and services.			
Project Section - Current V2024 Carlisle Site Terminus CAD/Model-Media View		Information Only	

No.	Date	Revision	Issued
1	02/12/24	Issued for LRD Planning	BKD
2	06/12/24	Issued for Pre-Planning	BKD
3	08/02/25	Issued for Pre-Planning	BKD
4	14/03/25	Issued for Pre-Planning	BKD

Project		Carlisle Site Residential Development		2ND FLOOR EUROPA HOUSE, BLOCK 9, HARCOURT CENTRE	
		52-54 Kimmage Rd West, Kimmage, Dublin 12		HARCOURT STREET, DUBLIN 2, IRELAND	
Drawing Title		Proposed Contiguous Elevations		bkdarchitects	
Drawing No		6269 LRD - P - 060		B R U K E - K E N N E D Y D O Y L E	
Scale	1:500@A1	Rev	4	Drawn	BKD
		Date	Dec 2024		